

WAREHOUSE FLOOR PLAN


SCALE : 1/16"=1'-0"

Electrical Legend:


- WALL MOUNTED AREA FIXTURE
- WALL MOUNTED FLOOD FIXTURE
- SERVICE DISCONNECT
- PANEL

LEGEND

- ⊕ FIRST AID KITS LOCATED IN RESTROOMS
- ☔ SHOWER STATION
- 📢 WHISTLE
- ⊗ FIRE EXTINGUISHER
- Ⓜ AED AUTOMATED EXTERNAL DEFIBRILLATOR
- 👁️ EYE WASH STATION
- EMERGENCY EXIT
- ⊘ NOT AN EXIT
- ➔ EXIT ROUTE

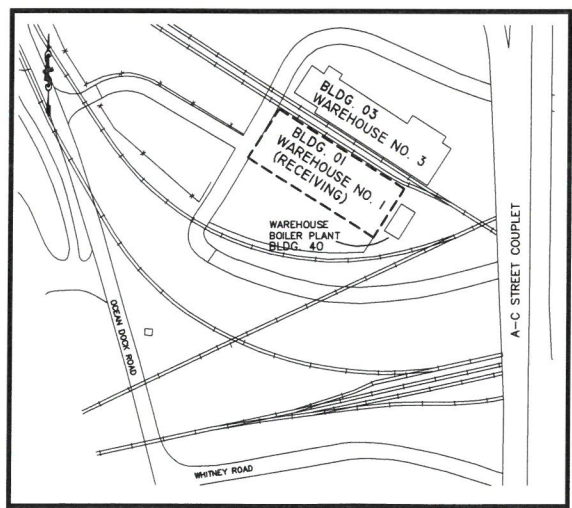


VICINITY MAP

 

REV.	DATE	BY	REVISION

ALASKA RAILROAD CORPORATION ENGINEERING SERVICES P.O. BOX 107500, ANCHORAGE, ALASKA 99510-7500		
PROJECT : EMERGENCY LOCATE PLAN BLDG 1 - WAREHOUSE NO. 1		
TITLE : FLOOR PLAN 1ST FLOOR		
DESIGNED BY: SM	SCALE : AS NOTED	AFE NO.:
DRAWN BY: rsm	DATE : 11/9/12	ACAD FILE:
CHECKED BY: SM		DWG NO. 1 OF 1
APPROVED BY: SM		

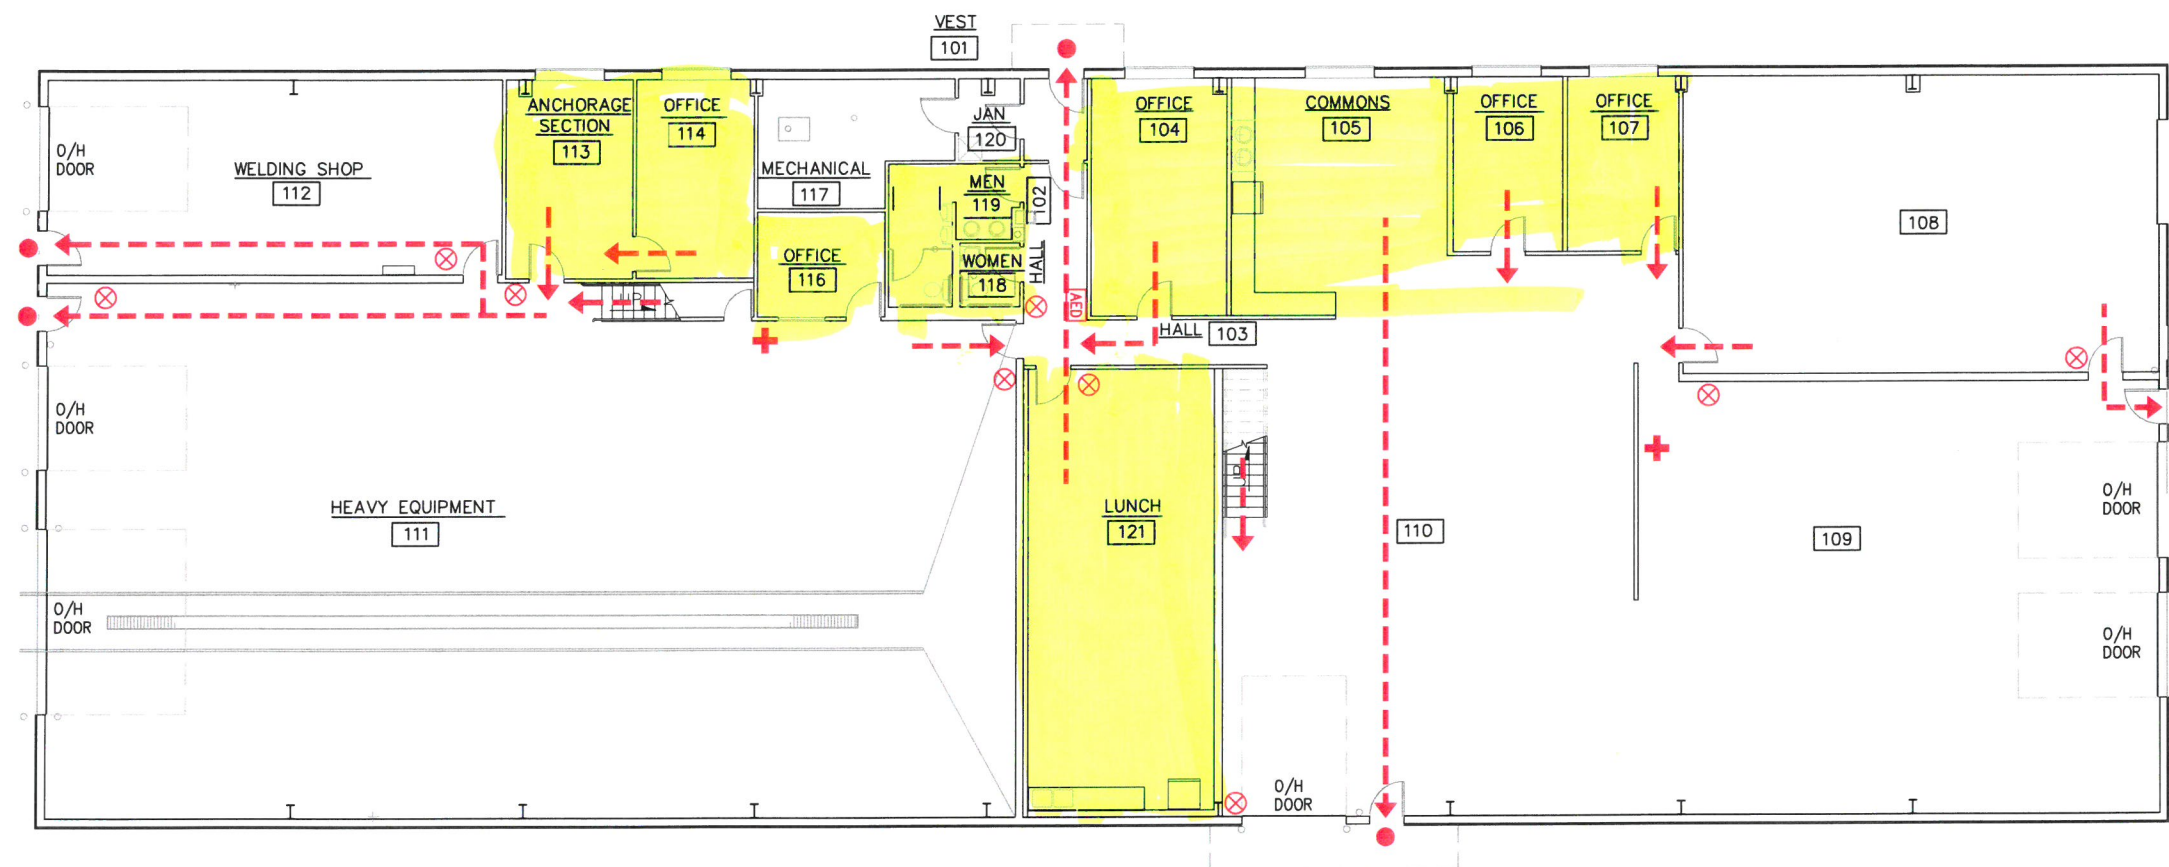


OVERALL FLOOR PLAN

SCALE: 1/16"=1'-0"

LEGEND

 
- +** FIRST AID KITS LOCATED IN RESTROOMS
- SHOWER STATION
- WHISTLE
- FIRE EXTINGUISHER
- AUTOMATED EXTERNAL DEFIBRILLATOR
- EYE WASH STATION
- EMERGENCY EXIT
- NOT AN EXIT
- - - - ->** EXIT ROUTE




REV.	DATE	BY	REVISION

ALASKA RAILROAD CORPORATION ENGINEERING SERVICES P.O. BOX 107500, ANCHORAGE, ALASKA 99510-7500		
PROJECT : EMERGENCY EXIT PLAN BLDG 6 - ENGINEERING SHOP		
TITLE: FLOOR PLAN 1ST FLOOR		
DESIGNED BY: ARRC	SCALE : AS NOTED	A/E NO.:
DRAWN BY: rsm	DATE : 11/8/12	ACAD FILE:
CHECKED BY: ARRC		DWG NO. 1 OF 1
APPROVED BY: ARRC		


Everything BUT

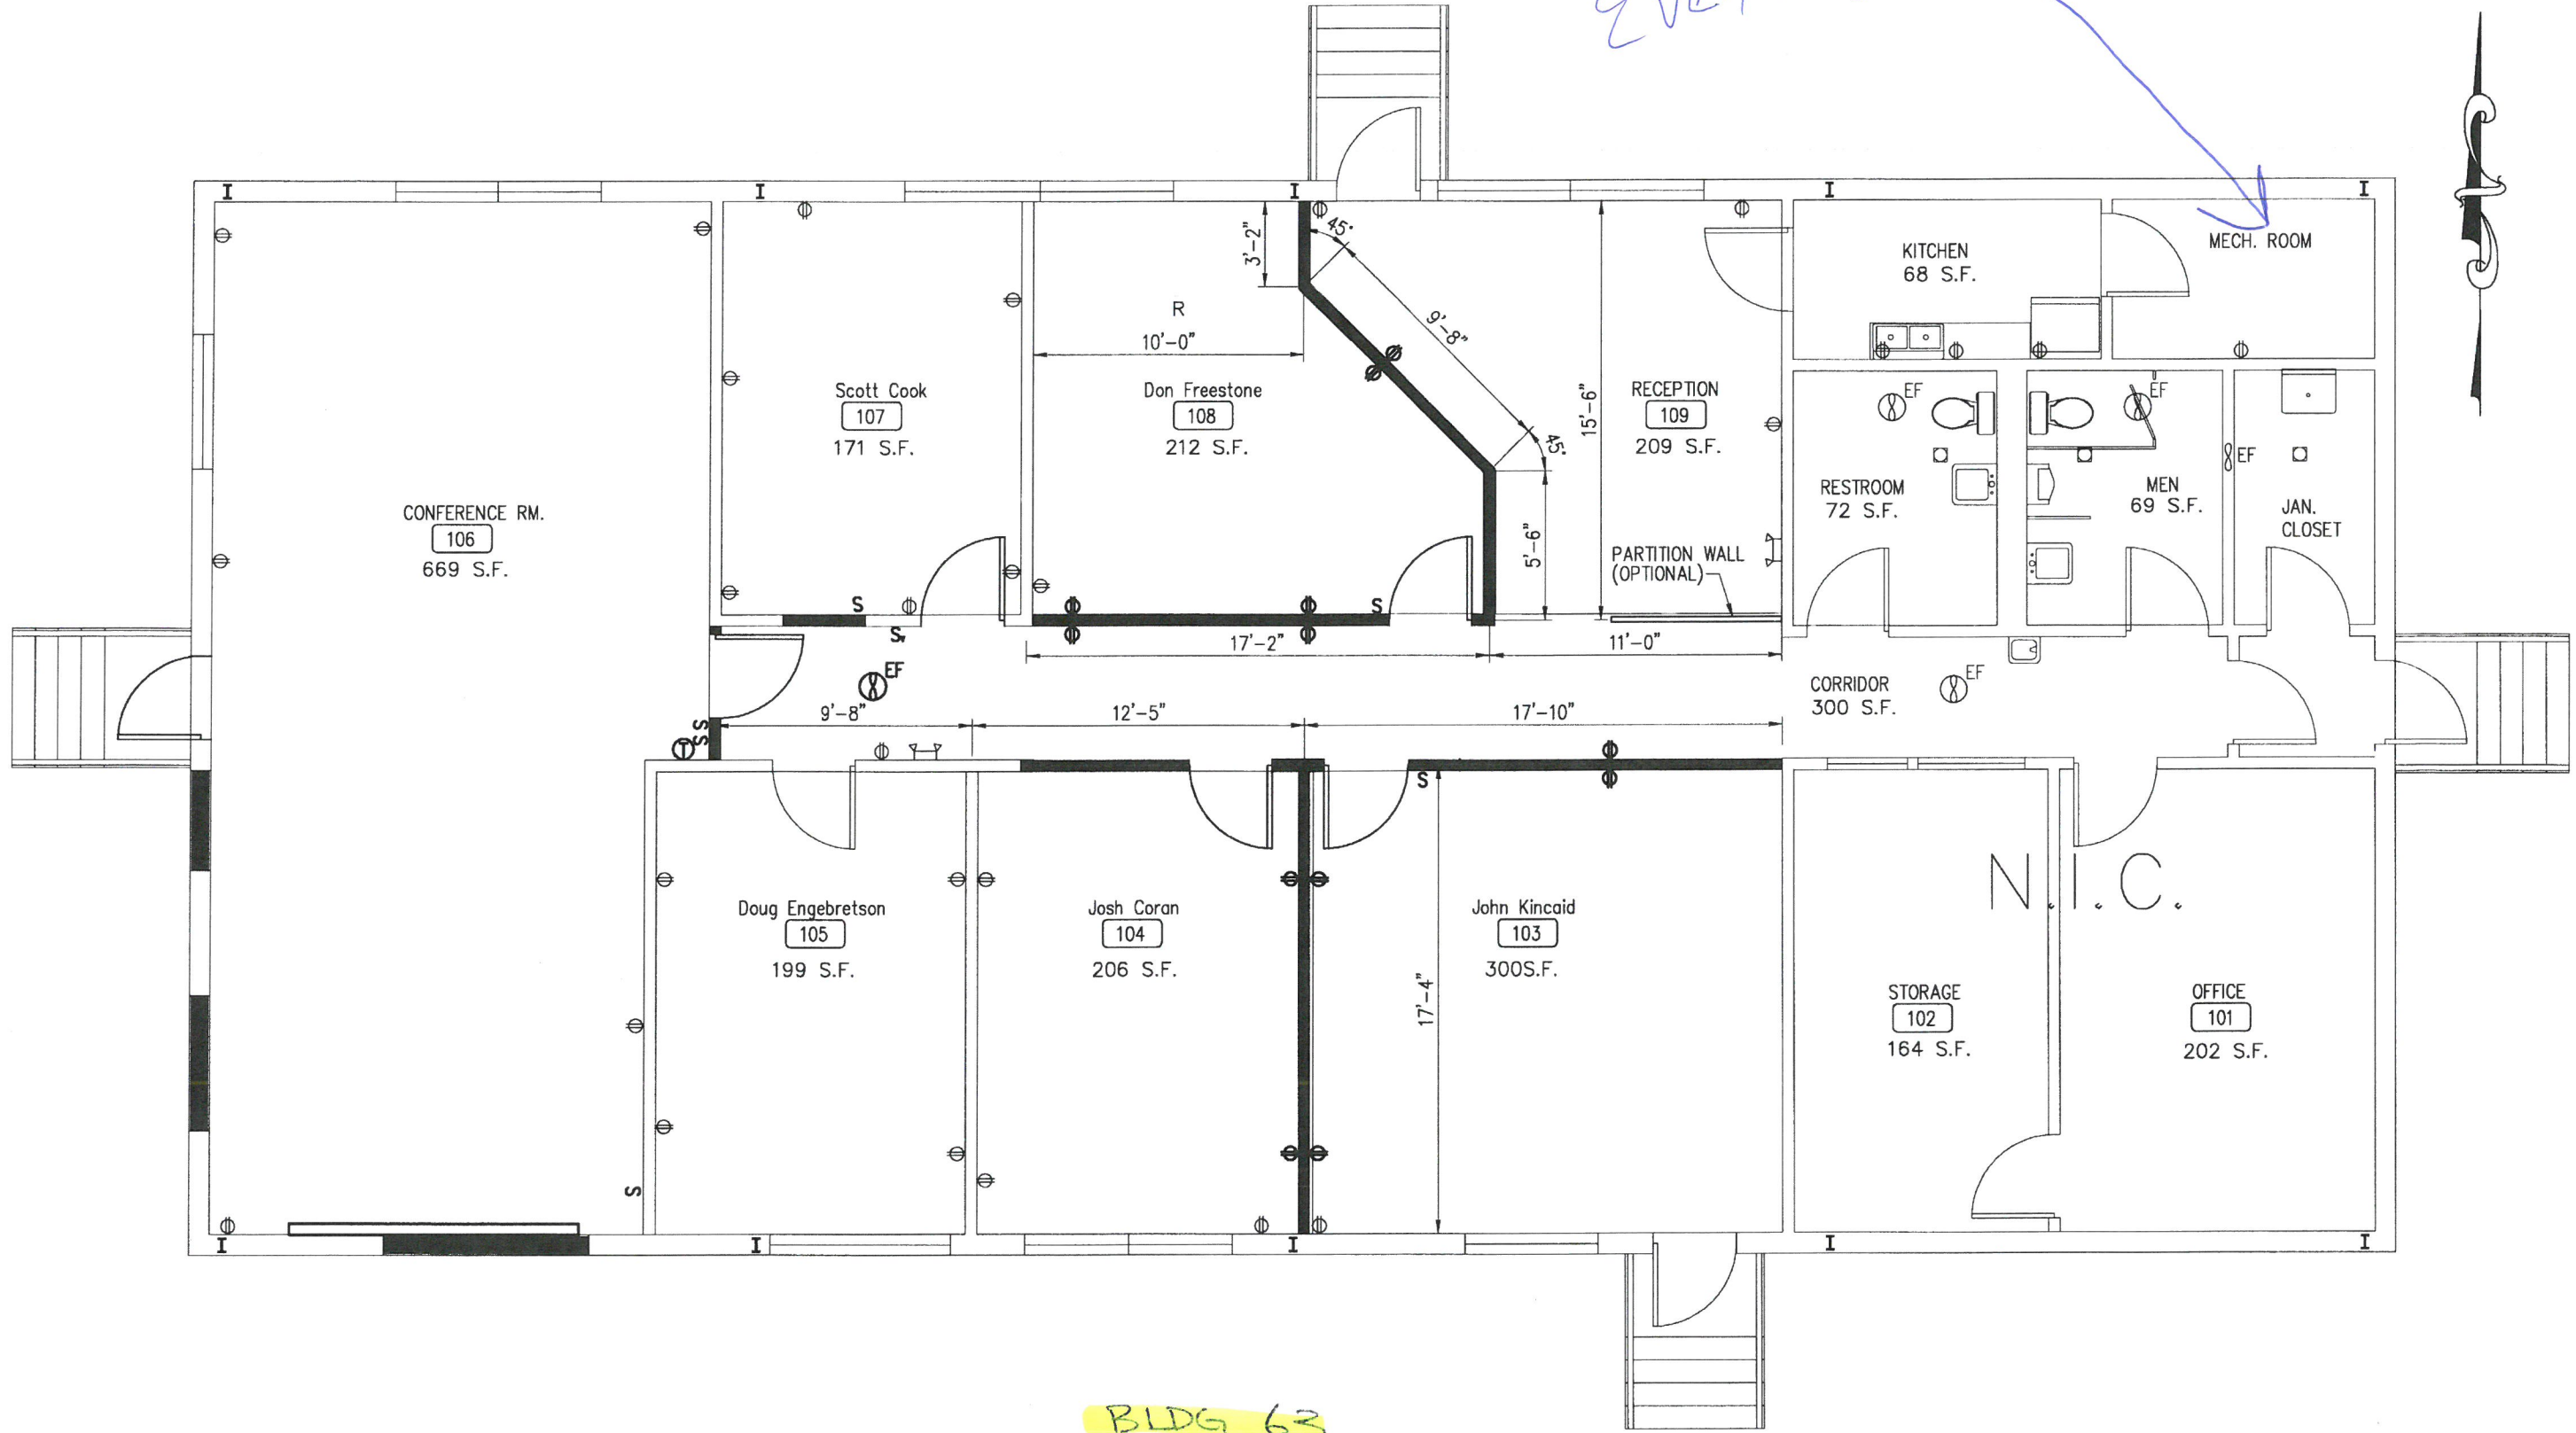




BLDG 63

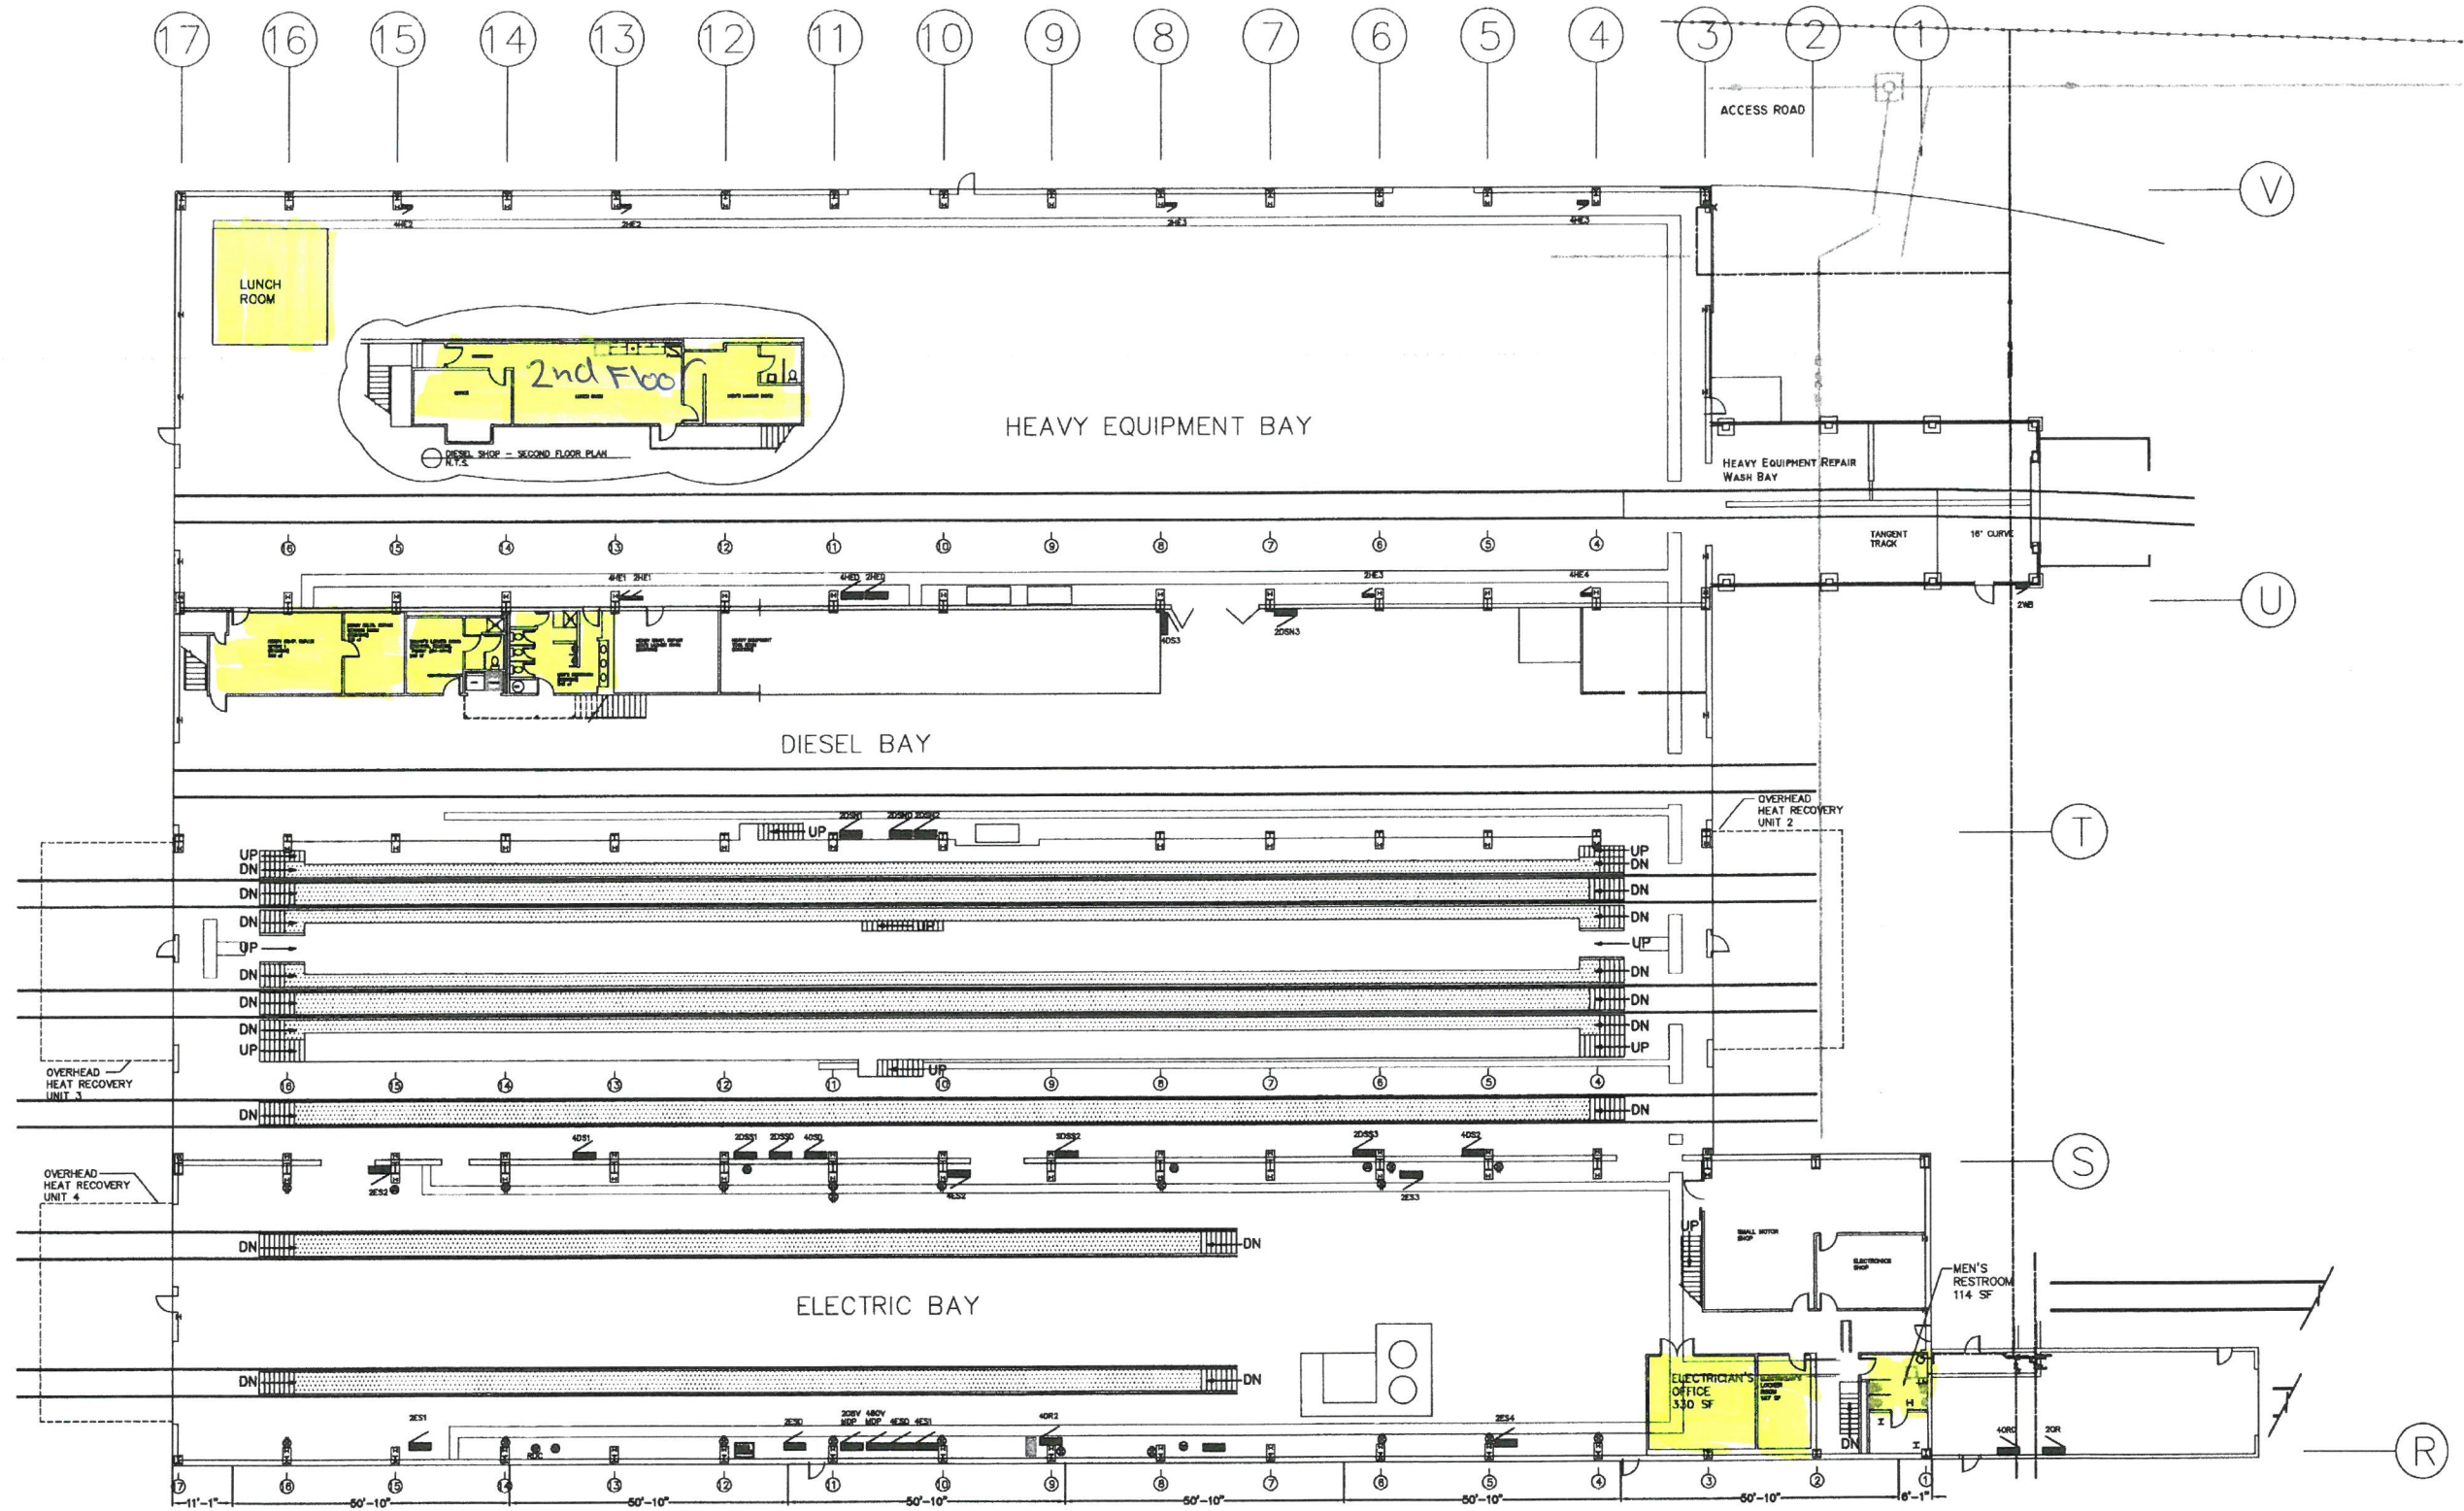

⊙ DIESEL SHOP-BUILDING 26
N.T.S

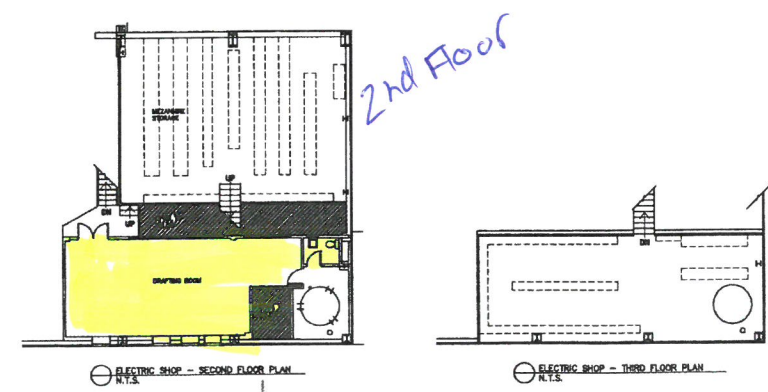

2nd Floor

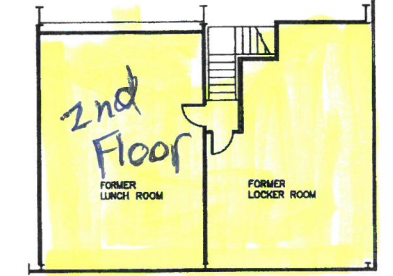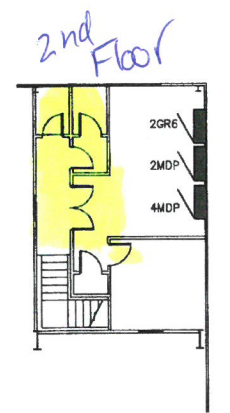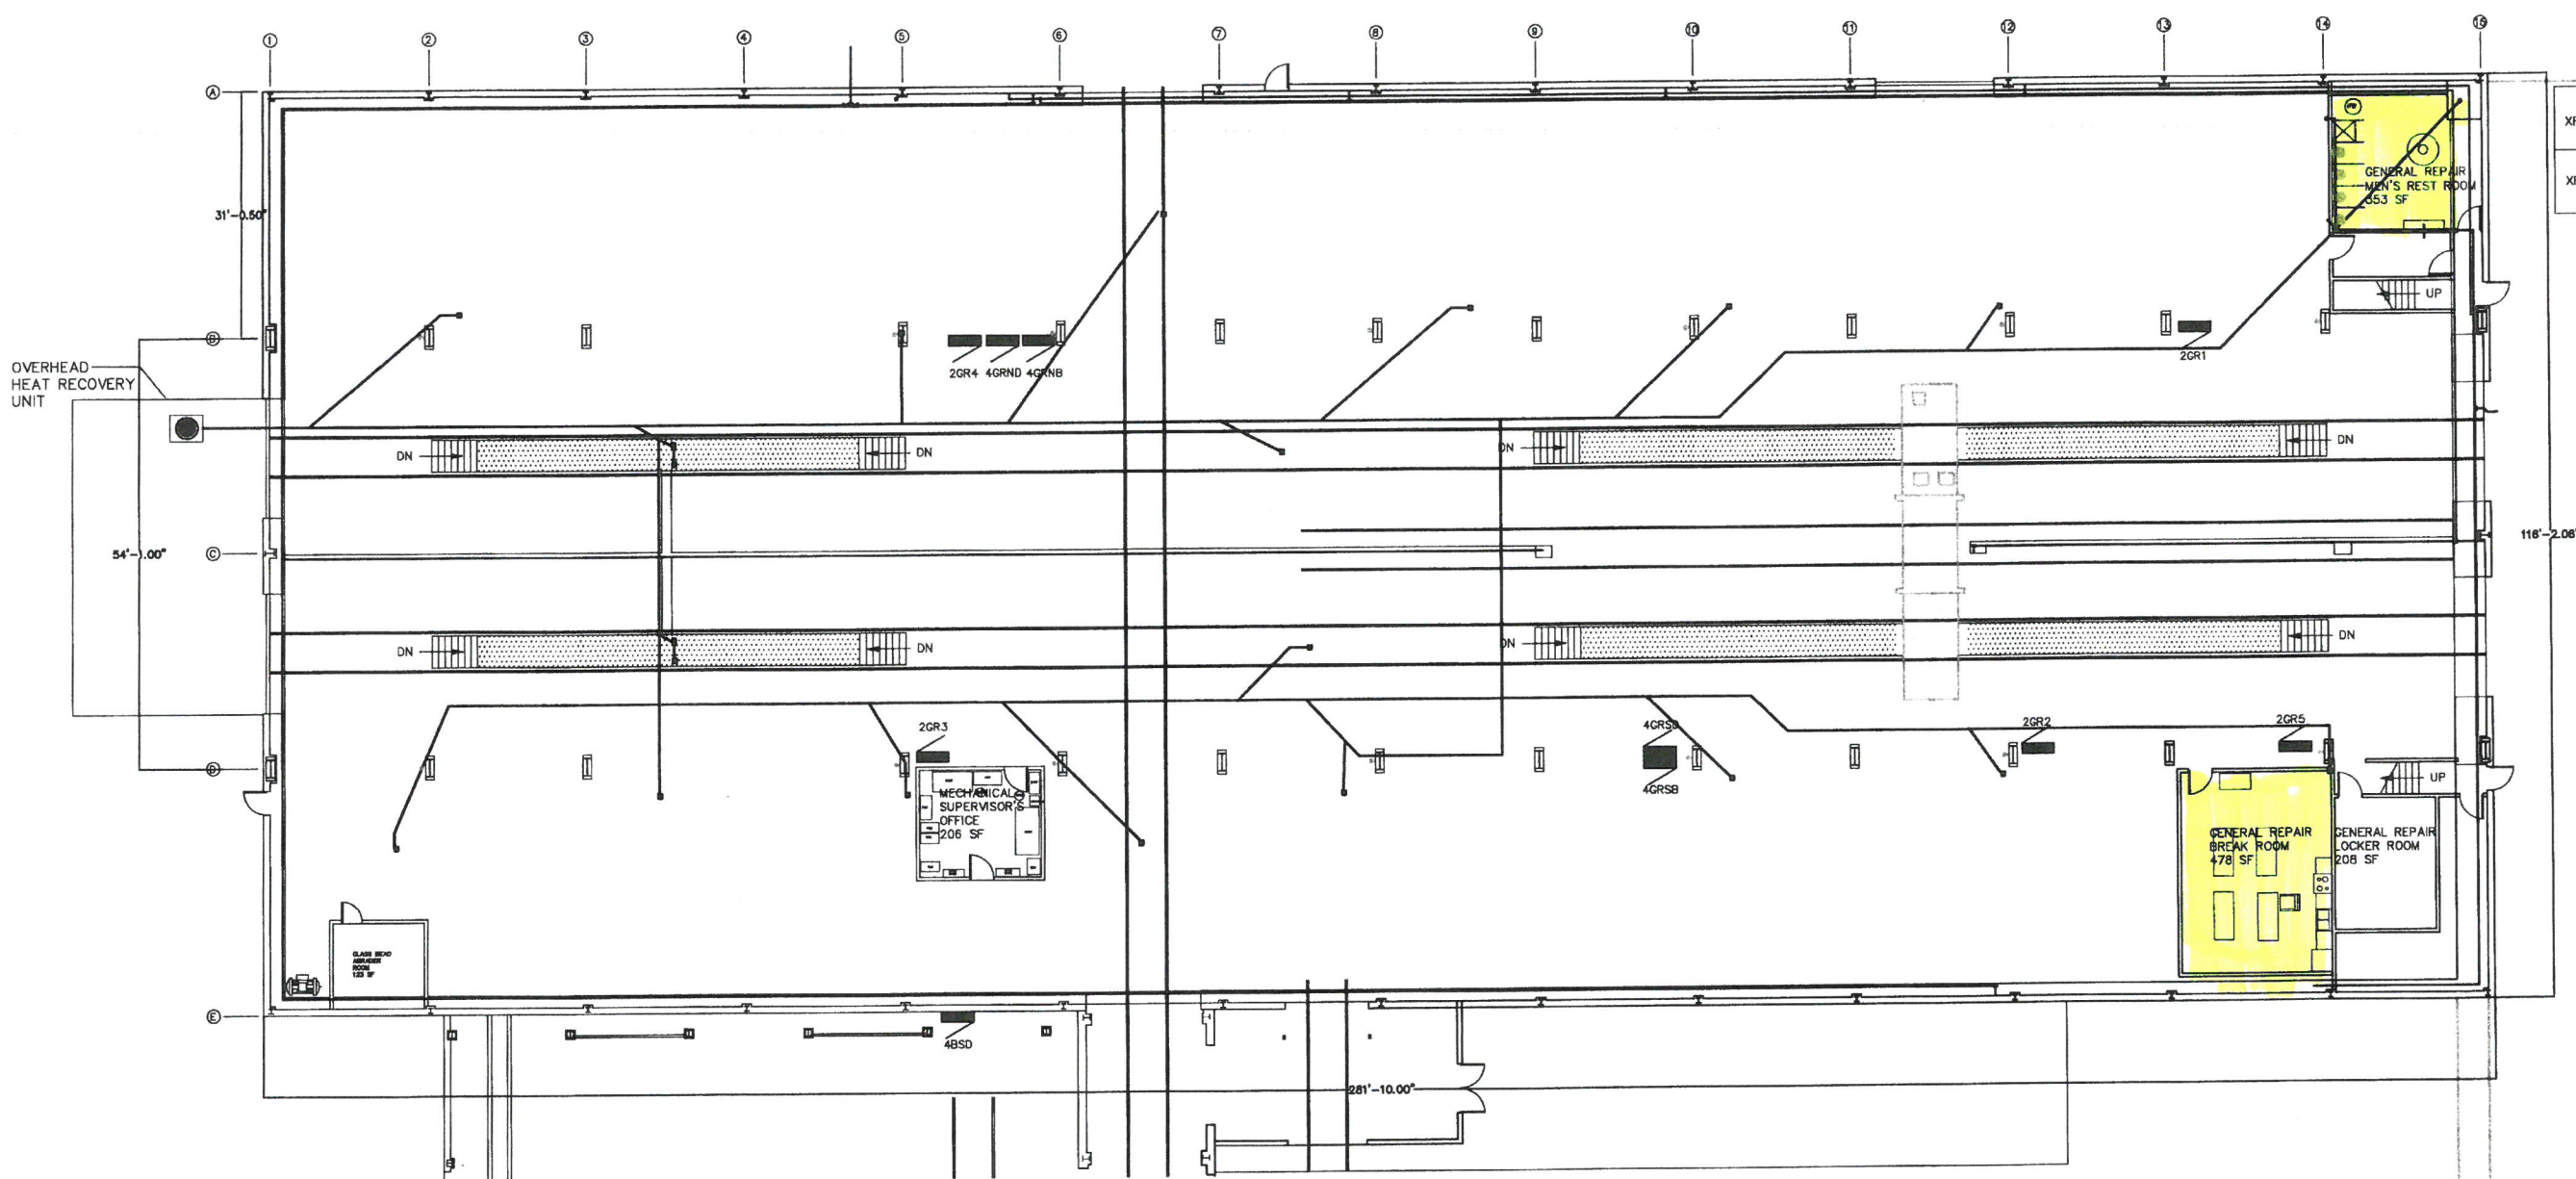


 GENERAL REPAIR SHOP
 N.T.S.

BLDG 27

